

KEY PLAN
SCALE: N.T.S.

NOTE:
LOCATION OF UNDERGROUND STRUCTURES AS SHOWN ARE BASED ON THE BEST INFORMATION AVAILABLE BUT NO GUARANTEE IS GIVEN THAT ALL EXISTING UTILITIES ARE SHOWN OR THAT THE GIVEN LOCATIONS ARE EXACT. CONFIRMATION OF EXISTENCE AND EXACT LOCATION OF ALL SERVICES MUST BE OBTAINED FROM THE INDIVIDUAL UTILITIES BEFORE PROCEEDING WITH CONSTRUCTION.


WARNING

1. NOTIFY THE GAS COMPANY OF THE PROPOSED LOCATION OF EXCAVATION.
2. TAKE PRECAUTION TO AVOID DAMAGE TO GAS COMPANY INSTALLATIONS.
3. SEE PROVINCIAL REGULATION 210/01 FOR DETAILS.

METRIC
WHOLE NUMBERS INDICATE MILLIMETRES
DECIMALIZED NUMBERS INDICATE METRES

NOTES:

1. SURVEY PERFORMED BY KGS GROUP, (2024/03/19) SURVEY COMPLETED IN NAD83, CSRS, UTM16, CGVD2013.
2. REFER TO DWG C01.00 FOR GENERAL NOTES

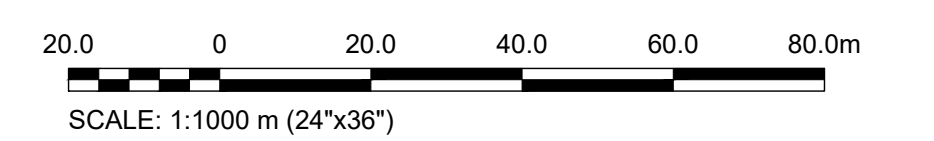

PROPOSED OVERALL SITE PLAN
SCALE: 1:1000

EXISTING FEATURES:		DESIGN FEATURES:	
EDGE OF ASPHALT	TOP OF SLOPE	SANITARY SEWER	SANITARY SEWER
CONCRETE CURB	TREE LINE	MAINTENANCE HOLE	MAINTENANCE HOLE
WATERMAIN	BUILDING	CLEANOUT	CLEANOUT
CURBSTOP	GUARD RAIL		
SANITARY SEWER	ASPHALT ROAD/PARKING AREA		
MAINTENANCE HOLE	GRANULAR ROAD		
STORM SEWER	CONCRETE		
DITCH	OVERHEAD UTILITY LINE		
CULVERT	HYDRO POLE		
GAS LINE	TREE		
FIRE HYDRANT & VALVE			
WATERMAIN TEE			

I.D.	STATION	NORTHING	EASTING	T/O GRATE	OPSD
NEW MH#1	1+356	5429893.996	407026.962	225.20m	701.010
NEW MH#2	1+274	5429892.992	406945.144	225.34m	701.010
NEW MH#3	1+192	5429892.082	406862.987	225.36m	701.010
NEW MH#4	1+107	5429891.958	406777.491	226.46m	701.010
NEW MH#5	1+011	5429887.679	406777.661	228.14m	701.010
EXIST. MH#7	1+000	5429989.948	406785.239	228.02m	701.010

STRUCTURE INFORMATION CHART

0	26/05/06	ISSUED FOR TENDER		
NO.	YY/MM/DD	DESCRIPTION	DESIGN BY	DESIGN CHECK

REVISIONS / ISSUE

CLIENT:

PROJECT:
NIPIGON MEMORIAL DISTRICT HOSPITAL SEWER REALIGNMENT

DWG. DESCRIPTION:
PROPOSED OVERALL SITE PLAN

AUTHENTICATION FOR CURRENT REVISION

ENG. STAMP

KGS GROUP	DESIGN BY:	MVP / JK	DATE (YY/MM/DD):	25/05/13
	DESIGN CHECK:		DATE:	26/04/28
	DRAWN BY:	NY	DATE:	25/05/13
	DWG CHECK:		DATE:	26/04/28
DWG. NO.	24-0847-001	C03.00	REV.	0

Filename: \\kgs-alfn-dsai\Projects\2024\24-0847-001\DWG\Mun\24-0847-001 - Tab C03.00 Plotted By: KMaumala 26/05/06 [Tue 1:33pm] 24"x36" PLOT SCALE: 1"=1'