


PLAN VIEW STA 1+000 TO 1+110
SCALE: 1:250


- NOTES:**
1. SURVEY PERFORMED BY KGS GROUP. (2024/03/19) SURVEY COMPLETED IN NAD83, CSRS, UTM16, CGVD2013.
 2. REFER TO DWG C01.00 FOR GENERAL NOTES

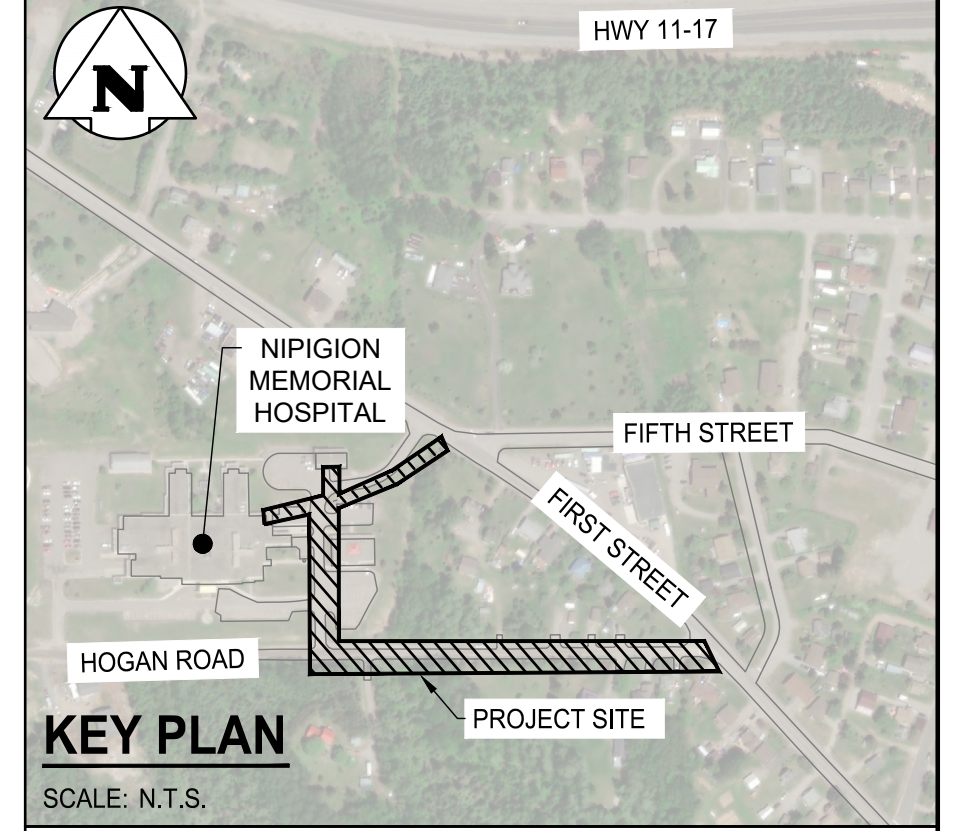


WARNING

1. NOTIFY THE GAS COMPANY OF THE PROPOSED LOCATION OF EXCAVATION.
2. TAKE PRECAUTION TO AVOID DAMAGE TO GAS COMPANY INSTALLATIONS.
3. SEE PROVINCIAL REGULATION 210/01 FOR DETAILS.

METRIC
WHOLE NUMBERS INDICATE MILLIMETRES
DECIMALIZED NUMBERS INDICATE METRES

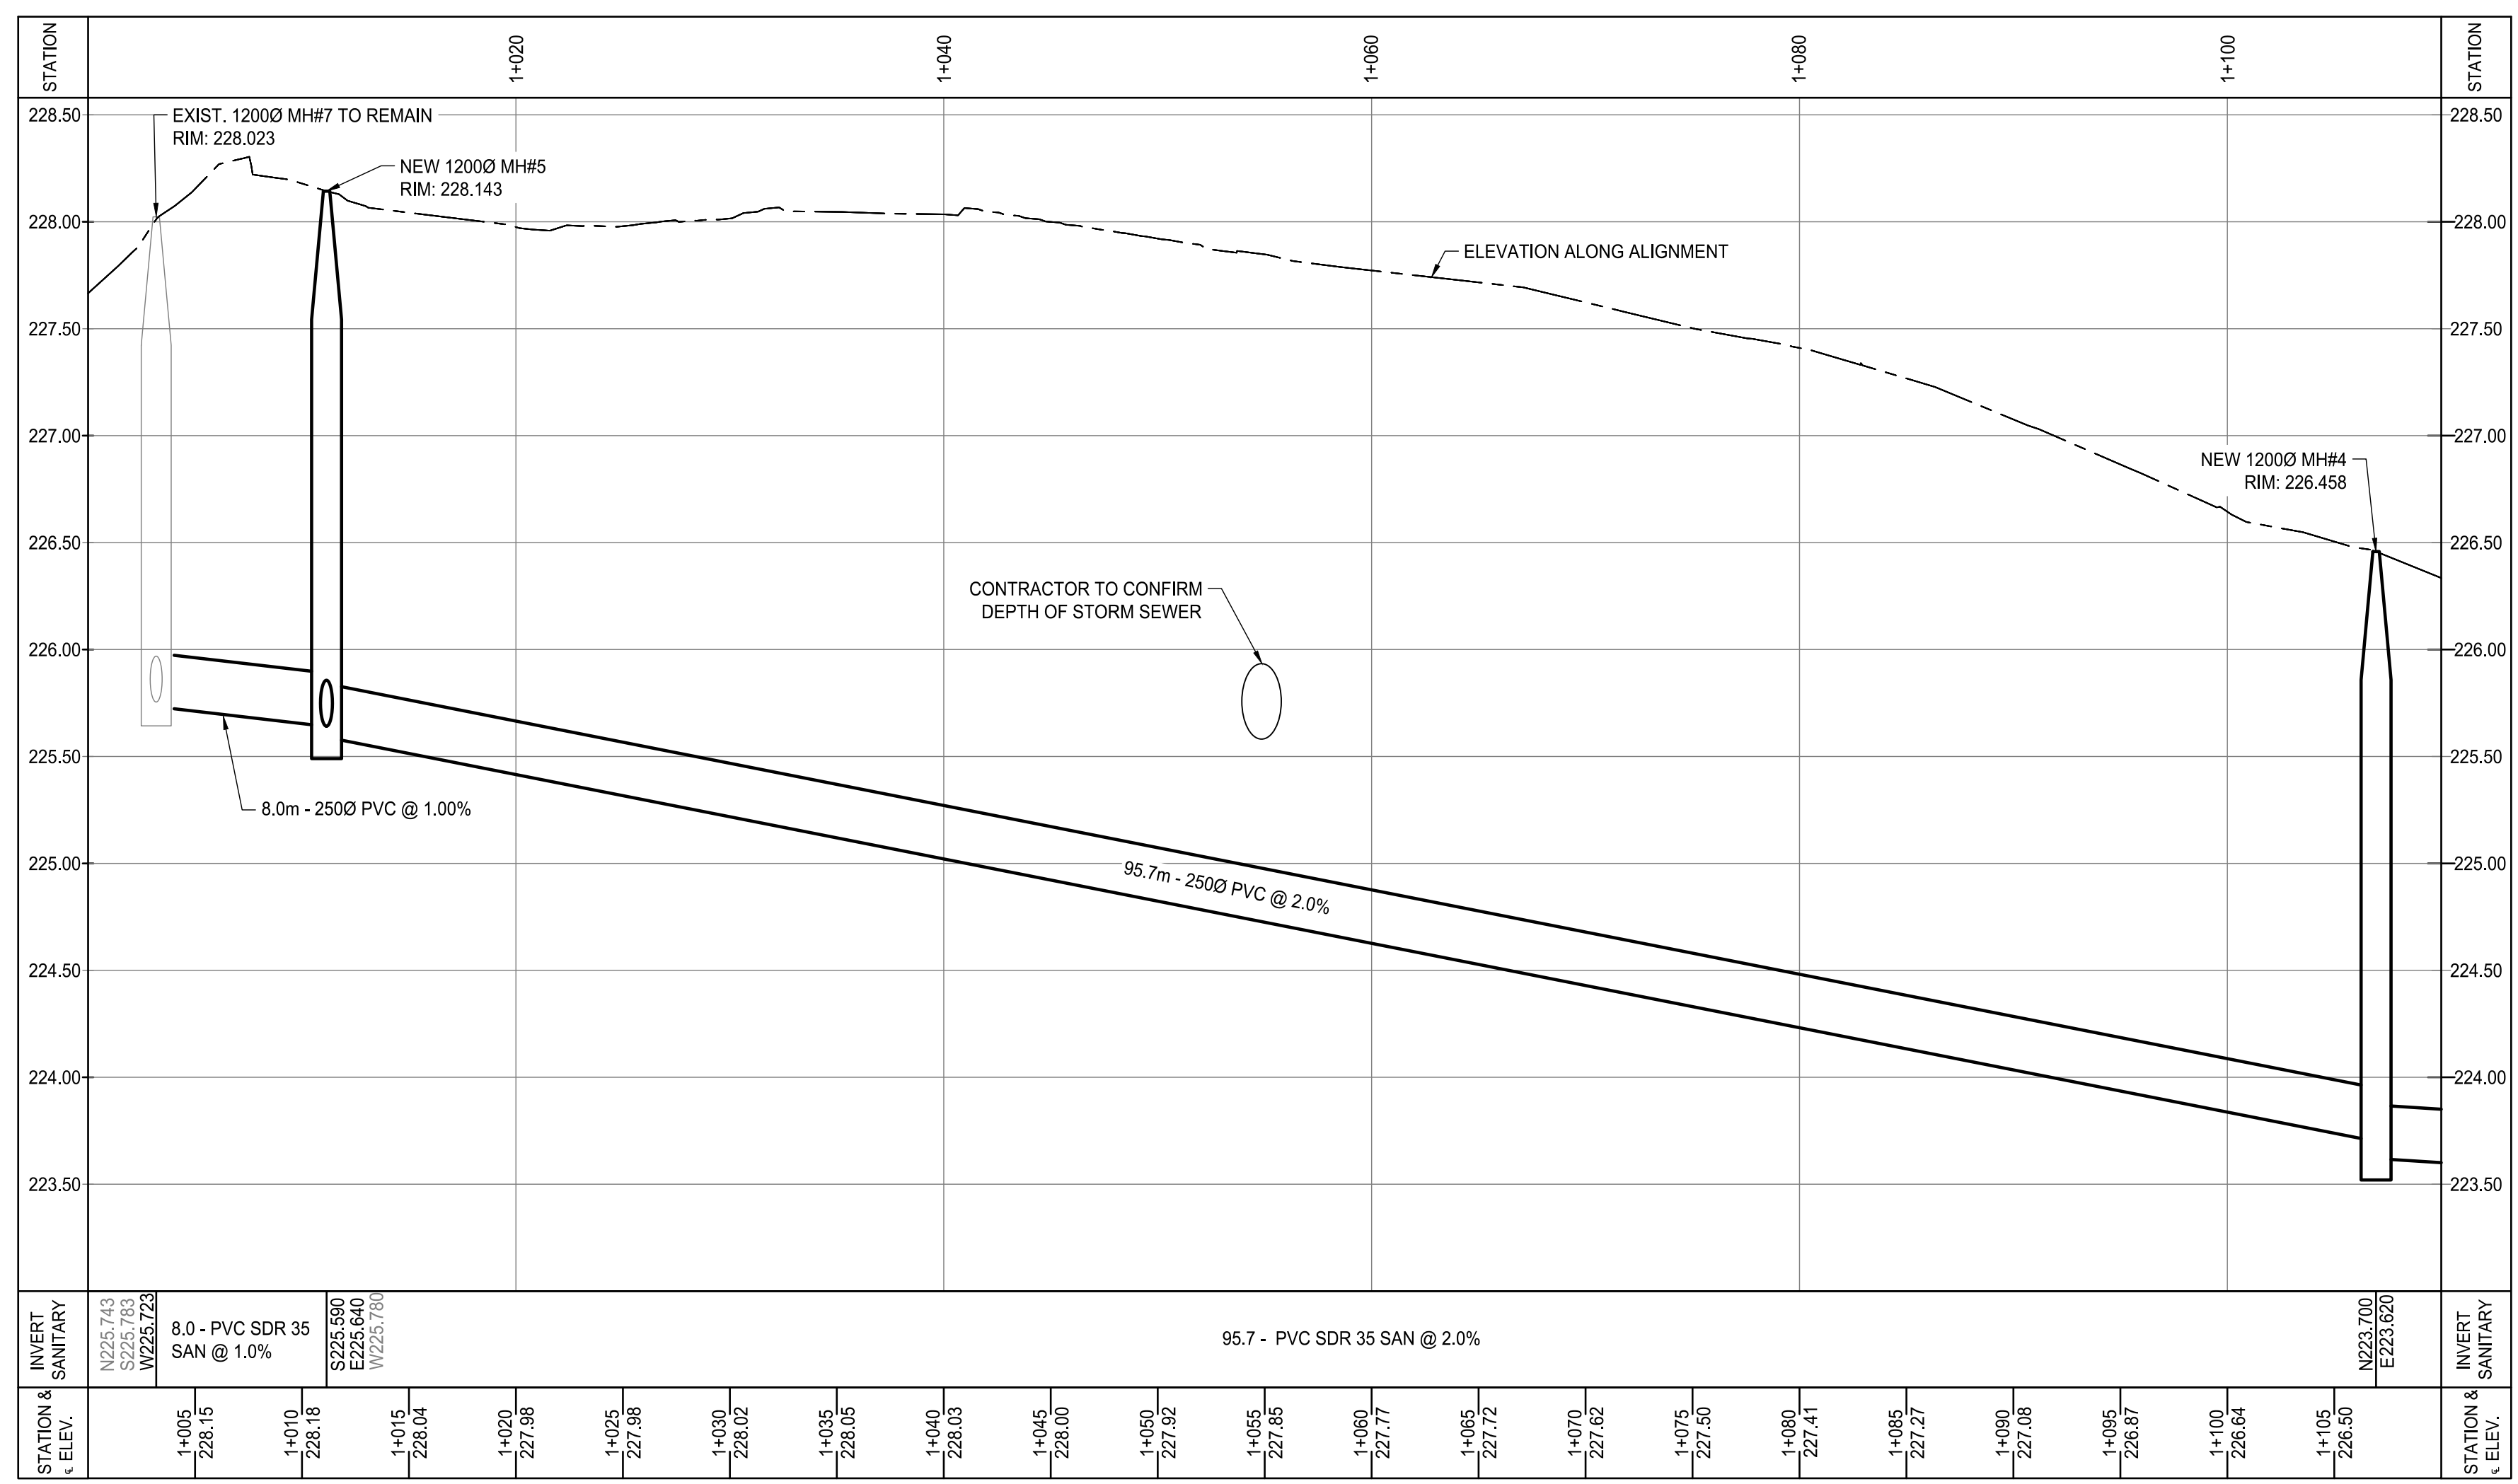

PROFILE STA 1+000 TO 1+110
SCALE: H:1:250
V:1:25

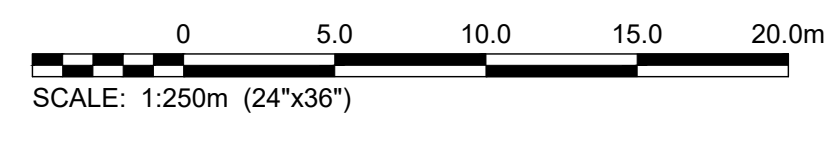

LEGEND

DESIGN FEATURES:

- SANITARY SEWER
- SANITARY MAINTENANCE HOLE

EXISTING FEATURES:

- EDGE OF ASPHALT
- CONCRETE CURB
- WATERMAIN
- SANITARY SEWER
- SANITARY MAINTENANCE
- DITCH
- CULVERT
- GAS LINE
- FIRE HYDRANT
- WATERMAIN TEE
- HYDRO POLE
- TOP OF SLOPE
- TREE LINE
- BUILDING
- ASPHALT ROAD / PARKING AREA
- GRANULAR ROAD
- CONCRETE
- OVERHEAD UTILITY LINE
- APPROX. PROPERTY LINE

0	26/05/06	ISSUED FOR TENDER		
NO.	YY/MM/DD	DESCRIPTION	DESIGN BY	DESIGN CHECK
REVISIONS / ISSUE				

CLIENT:

PROJECT:

NIPIGON MEMORIAL DISTRICT HOSPITAL SEWER REALIGNMENT

DWG. DESCRIPTION:

PLAN AND PROFILE STA: 1+000 TO 1+110

AUTHENTICATION FOR CURRENT REVISION

ENG. STAMP	DESIGN BY:	MVP / JK	DATE (YY/MM/DD):	25/05/13
	DESIGN CHECK:		DATE:	26/04/28
	DRAWN BY:	NY	DATE:	25/05/13
	DWG CHECK:		DATE:	26/04/28

DWG. NO.	24-0847-001	C04.00	REV.	0
----------	-------------	--------	------	---

Filename: \\ggs-file-01\Projects\2024\24-0847-001\DWG\Mun24-0847-001 - Tab C04.00 Plotted By: KMaumula 26/05/2025 (Tue 1:33pm) 24"x36" PLOT SCALE: 1"=1'