


**PLAN VIEW STA 1+110 TO 1+240**  
SCALE: 1:250

- NOTES:**
1. SURVEY PERFORMED BY KGS GROUP, (2024/03/19)  
SURVEY COMPLETED IN NAD83, CSRS, UTM 16, CGVD2013.
  2. REFER TO DWG C01.00 FOR GENERAL NOTES

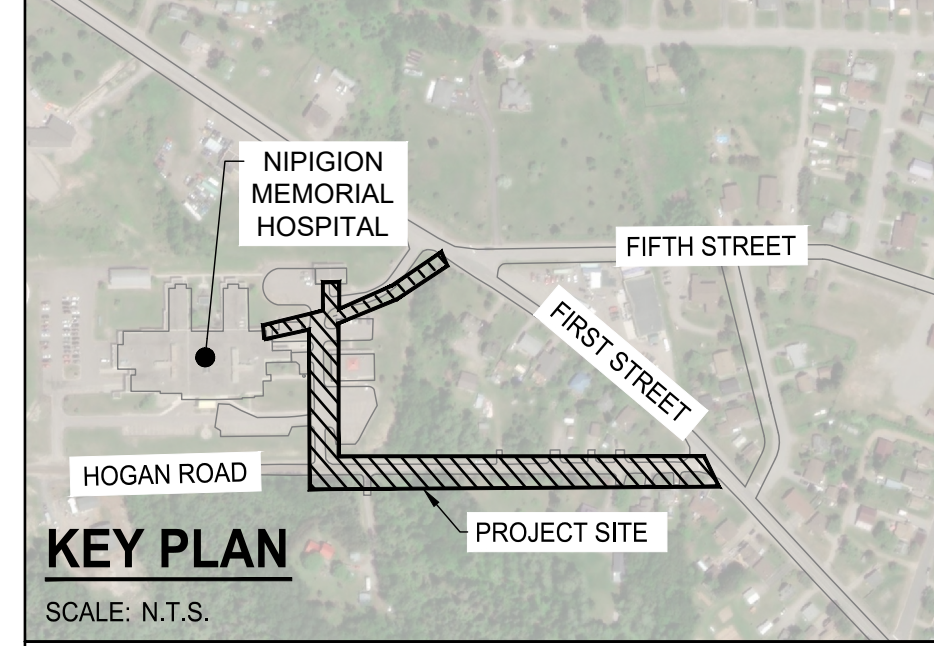

**NOTE:**  
LOCATION OF UNDERGROUND STRUCTURES AS SHOWN ARE BASED ON THE BEST INFORMATION AVAILABLE BUT NO GUARANTEE IS GIVEN THAT ALL EXISTING UTILITIES ARE SHOWN OR THAT THE GIVEN LOCATIONS ARE EXACT. CONFIRMATION OF EXISTENCE AND EXACT LOCATION OF ALL SERVICES MUST BE OBTAINED FROM THE INDIVIDUAL UTILITIES BEFORE PROCEEDING WITH CONSTRUCTION.

**WARNING**


1. NOTIFY THE GAS COMPANY OF THE PROPOSED LOCATION OF EXCAVATION.
2. TAKE PRECAUTION TO AVOID DAMAGE TO GAS COMPANY INSTALLATIONS.
3. SEE PROVINCIAL REGULATION 210/01 FOR DETAILS.

**METRIC**


WHOLE NUMBERS INDICATE MILLIMETRES  
DECIMALIZED NUMBERS INDICATE METRES

**LEGEND**

- DESIGN FEATURES:**
- SANITARY SEWER
  - MAINTENANCE HOLE
- EXISTING FEATURES:**
- EDGE OF ASPHALT
  - CONCRETE CURB
  - WATERMAIN
  - SANITARY SEWER
  - DITCH
  - CULVERT
  - GAS LINE
  - HYDRO POLE
  - TOP OF SLOPE
  - TREE LINE
  - BUILDING
  - ASPHALT ROAD
  - GRANULAR ROAD
  - CONCRETE
  - OVERHEAD UTILITY LINE
  - APPROX. PROPERTY LINE
  - GUARD RAIL
  - TREE

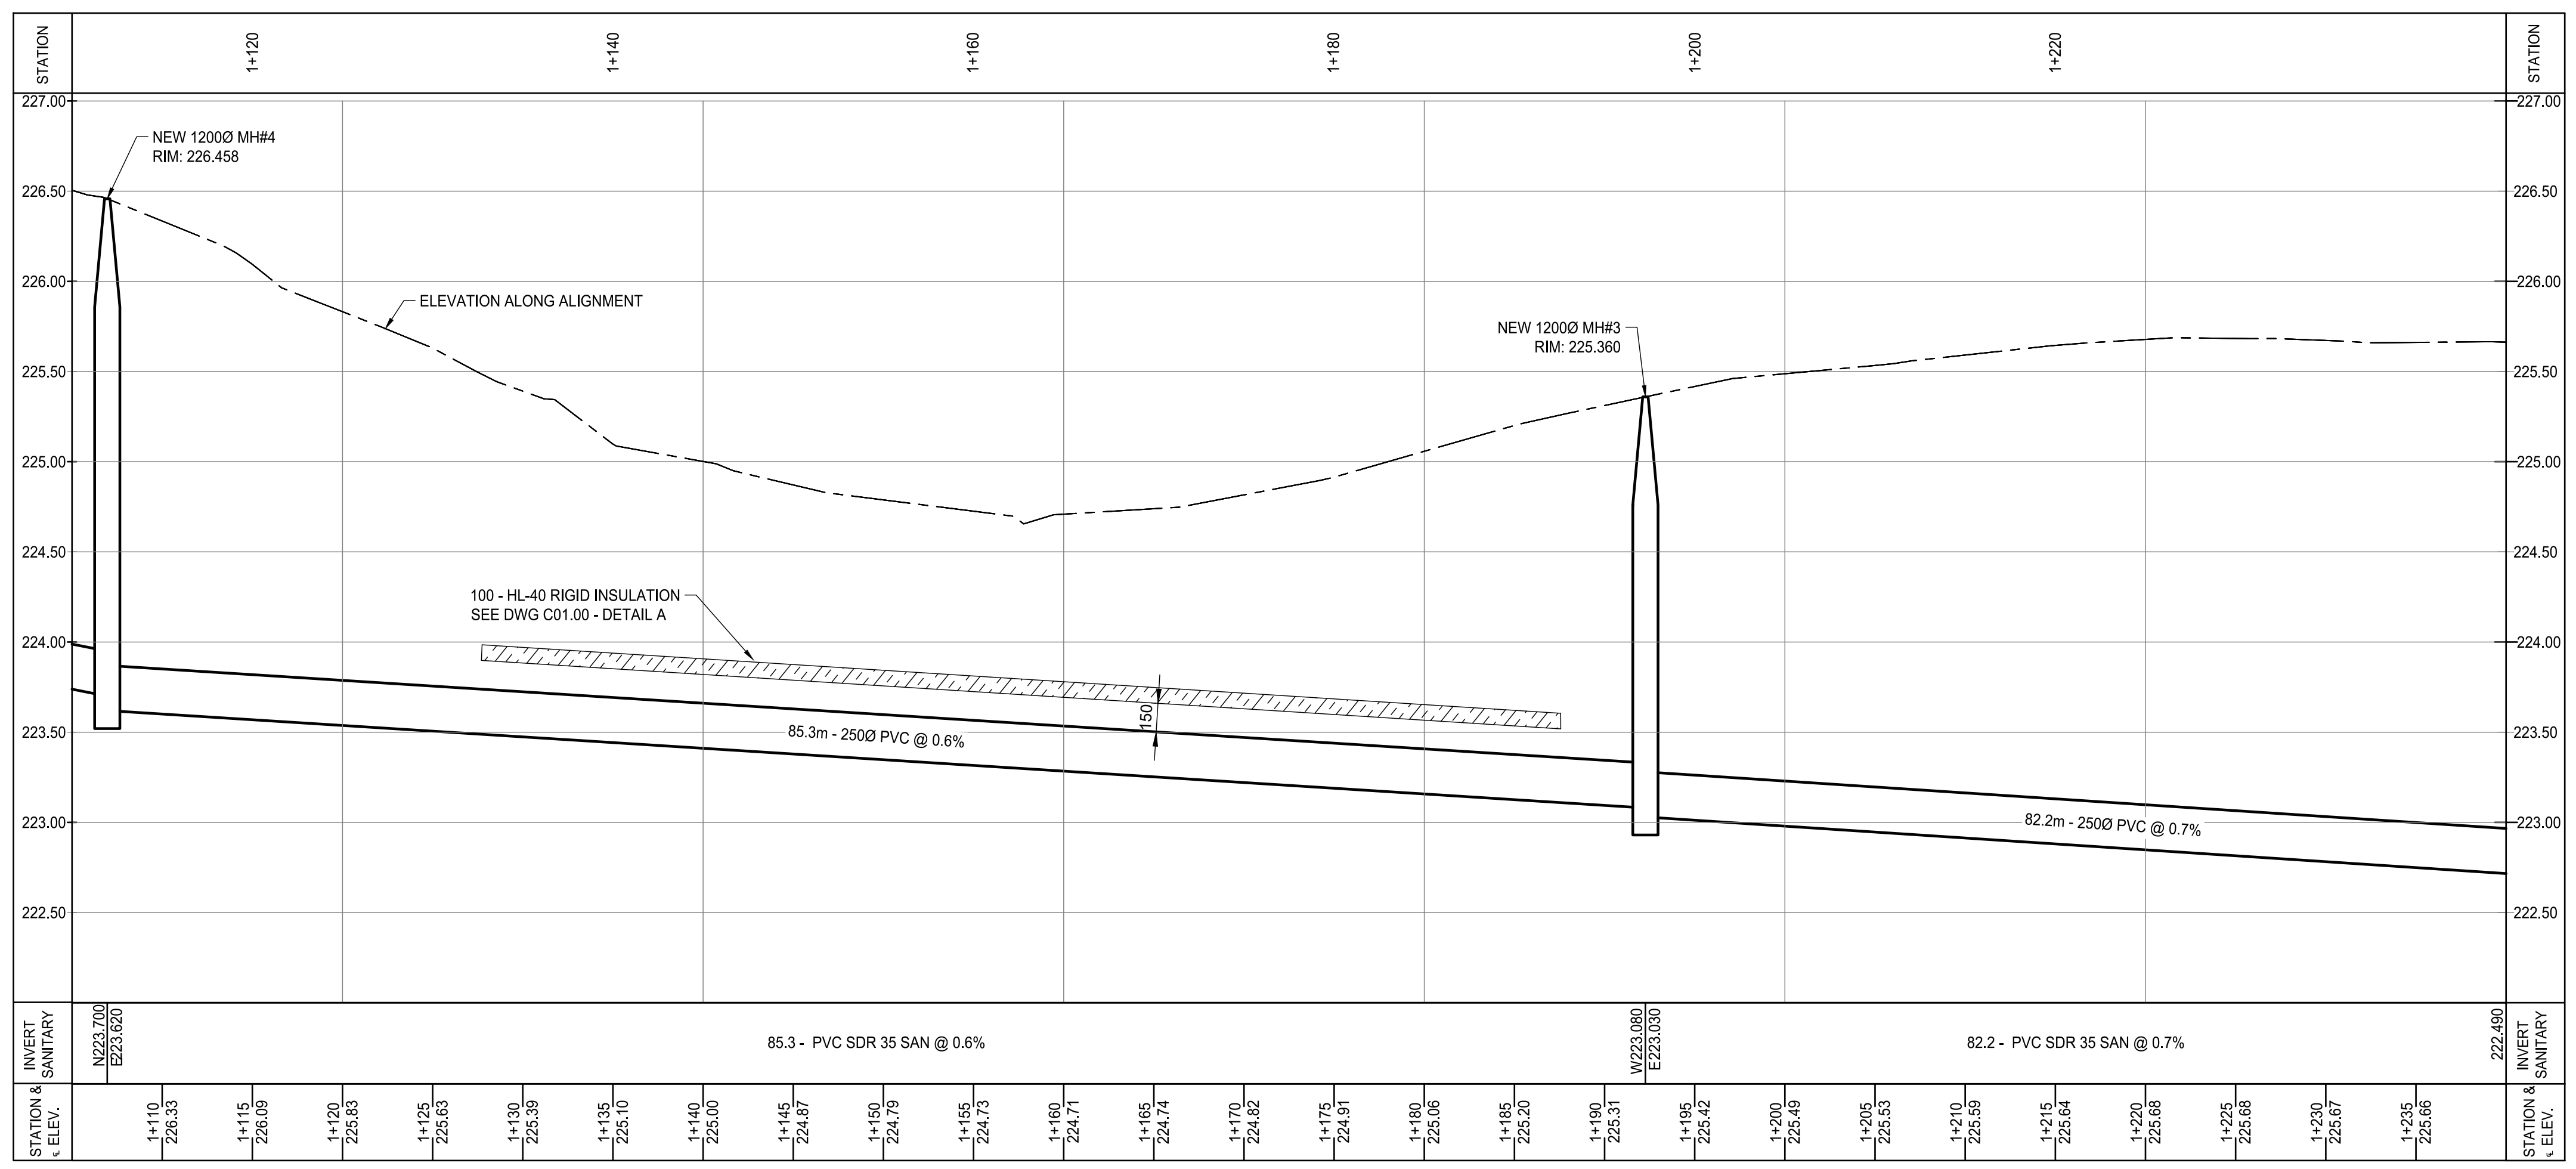

**PROFILE STA 1+105 TO 1+240**  
SCALE: H:1:250  
V:1:25

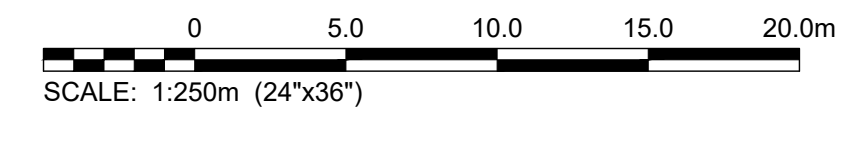

NO.	YY/MM/DD	DESCRIPTION	DESIGN BY	DESIGN CHECK
0	26/05/06	ISSUED FOR TENDER		

**REVISIONS / ISSUE**

CLIENT:

PROJECT:  
**NIPIGON MEMORIAL DISTRICT HOSPITAL SEWER REALIGNMENT**

DWG. DESCRIPTION:  
**PLAN AND PROFILE STA: 1+105 TO 1+240**

AUTHENTICATION FOR CURRENT REVISION

ENG. STAMP

DESIGN BY: MVP / JK	DATE (YY/MM/DD): 25/05/13
DESIGN CHECK:	DATE: 26/04/28
DRAWN BY: NY	DATE: 25/05/13
DWG CHECK:	DATE: 26/04/28

DWG. NO. 24-0847-001	C04.01	REV. 0
-------------------------	--------	-----------