



PLAN VIEW STA 1+240 TO 1+360
SCALE: 1:250

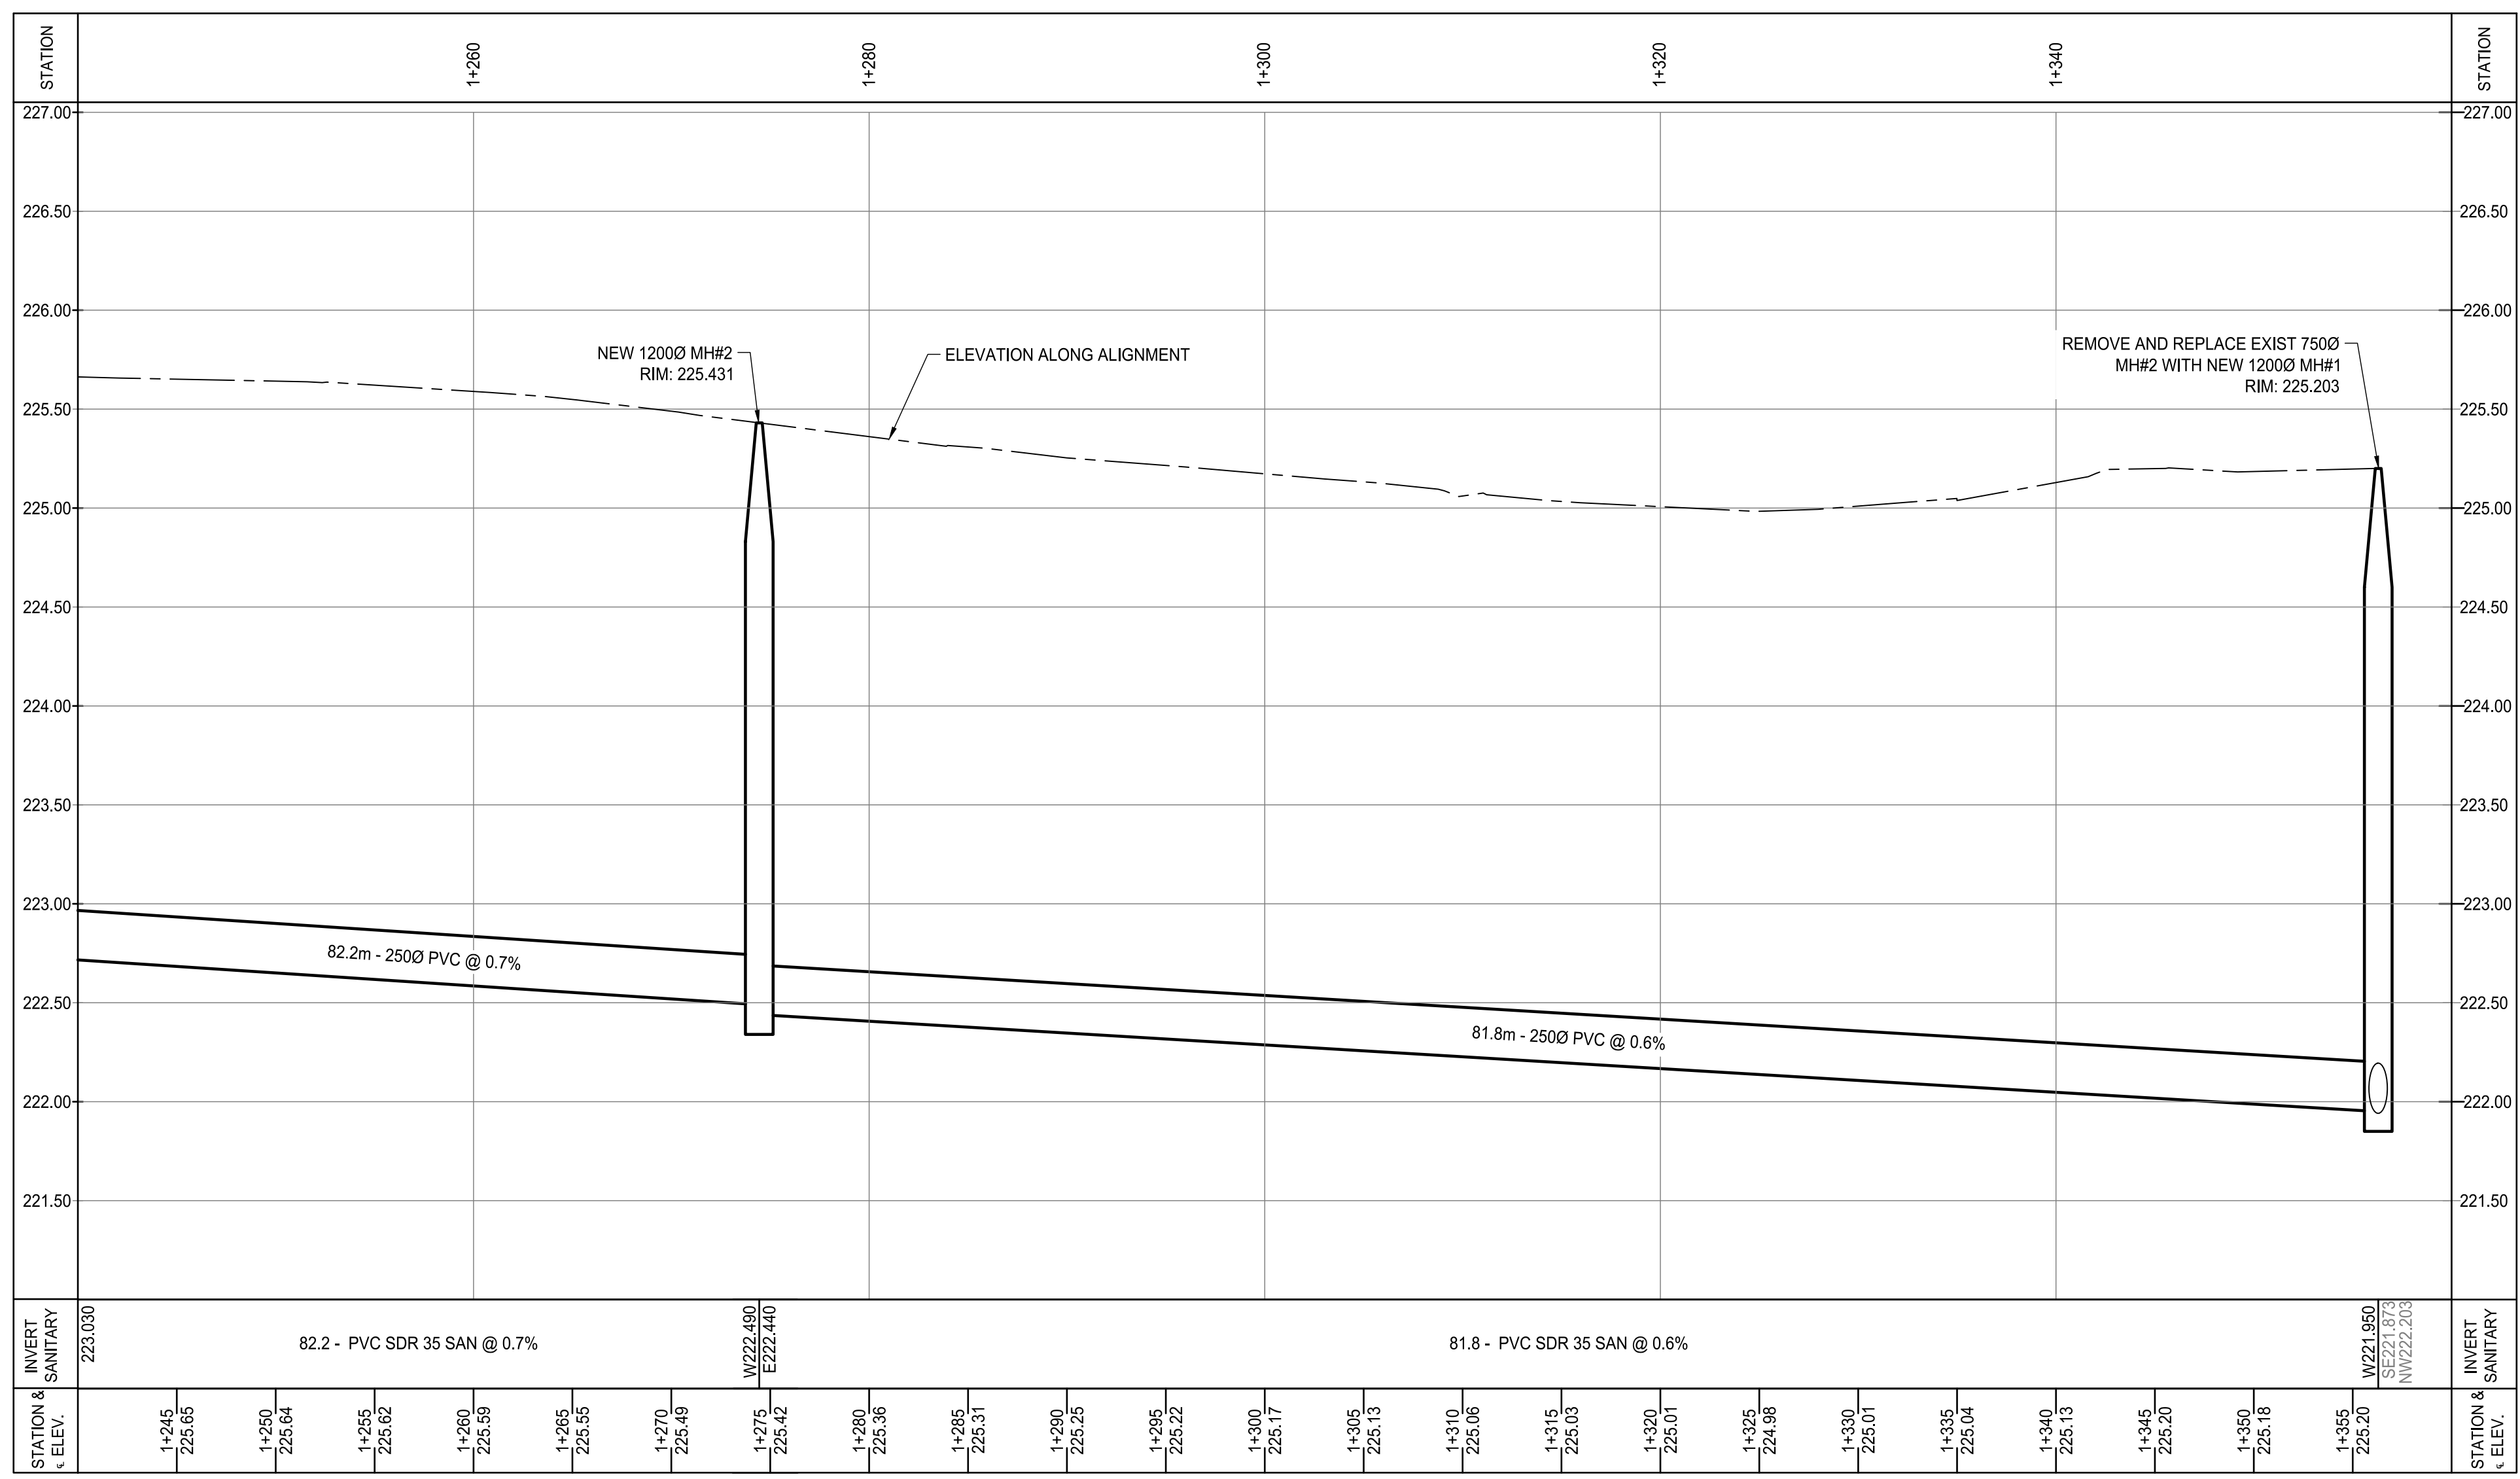

PROFILE STA 1+240 TO 1+360
SCALE: H:1:250
V:1:25

- NOTES:**
1. SURVEY PERFORMED BY KGS GROUP. (2024/03/19) SURVEY COMPLETED IN NAD83, CSRS, UTM16, CGVD2013.
 2. REFER TO DWG C01.00 FOR GENERAL NOTES

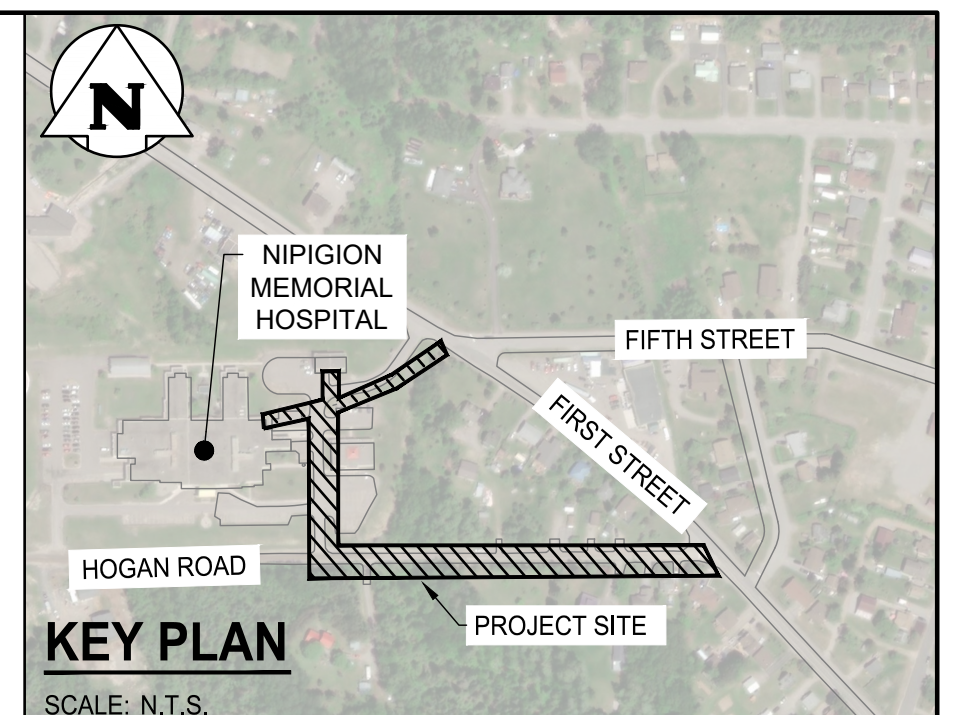

NOTE:
LOCATION OF UNDERGROUND STRUCTURES AS SHOWN ARE BASED ON THE BEST INFORMATION AVAILABLE BUT NO GUARANTEE IS GIVEN THAT ALL EXISTING UTILITIES ARE SHOWN OR THAT THE GIVEN LOCATIONS ARE EXACT. CONFIRMATION OF EXISTENCE AND EXACT LOCATION OF ALL SERVICES MUST BE OBTAINED FROM THE INDIVIDUAL UTILITIES BEFORE PROCEEDING WITH CONSTRUCTION.

- WARNING**
1. NOTIFY THE GAS COMPANY OF THE PROPOSED LOCATION OF EXCAVATION.
 2. TAKE PRECAUTION TO AVOID DAMAGE TO GAS COMPANY INSTALLATIONS.
 3. SEE PROVINCIAL REGULATION 210/01 FOR DETAILS.

METRIC
WHOLE NUMBERS INDICATE MILLIMETRES
DECIMALIZED NUMBERS INDICATE METRES

LEGEND

DESIGN FEATURES:

- SANITARY SEWER
- MAINTENANCE HOLE

EXISTING FEATURES:

- EDGE OF ASPHALT
- CONCRETE CURB
- WATERMAIN
- SANITARY SEWER
- SANITARY MAINTENANCE HOLE
- DITCH
- CULVERT
- GAS LINE
- FIRE HYDRANT
- WATERMAIN TEE
- CURBSTOP
- HYDRO POLE
- CLEANOUT
- TOP OF SLOPE
- TREE LINE
- BUILDING
- ASPHALT ROAD
- GRANULAR ROAD
- CONCRETE OVERHEAD UTILITY LINE
- APPROX. PROPERTY LINE
- GUARD RAIL
- TREE

| 0 | 26/05/06 | ISSUED FOR TENDER | | |
|-----|----------|-------------------|-----------|--------------|
| NO. | YYMMDD | DESCRIPTION | DESIGN BY | DESIGN CHECK |

CLIENT:
nipigon
a natural edge

PROJECT:
NIPIGON MEMORIAL DISTRICT HOSPITAL SEWER REALIGNMENT

DWG. DESCRIPTION:
PLAN AND PROFILE STA: 1+240 TO 1+360

AUTHENTICATION FOR CURRENT REVISION

ENG. STAMP

| | | | | |
|------------------|---------------|----------|----------------|----------|
| KGS GROUP | DESIGN BY: | MVP / JK | DATE (YYMMDD): | 25/05/13 |
| | DESIGN CHECK: | | DATE: | 26/04/28 |
| | DRAWN BY: | NY | DATE: | 25/05/13 |
| | DWG CHECK: | | DATE: | 26/04/28 |
| DWG. NO: | 24-0847-001 | C04.02 | REV: | 0 |

